

**JIM COLEMAN COMPANY**  
**HANNA**


World Class Manufacturing in Car Wash Equipment

HOME OFFICE: 5842 WEST 34th STREET  
HOUSTON, TEXAS 77062  
PH: 1-800-999-9878 FAX: 713-663-8624  
www.jccolmanco.com


OWNER: <b>JIM COLEMAN COMPANY</b> 5842 WEST 34th STREET HOUSTON, TX 77092			
SHEET NAME: <b>e-FUSION (MECHANICAL LAYOUT)</b>			
SCALE: AS SHOWN	DATE: 01/16/2012	DRAWN BY: J.TREVINO	APPROVED BY: J.TRUELOVE / R.WITTE
DRAWING A.K.O.:	EQUIPMENT A.K.O.:	FILE NAME: T:\W-e-FUSION\ef-M1.0.dwg	

ENGINEER SEAL OR APPROVAL:

SHEET: **ef-M1.0**

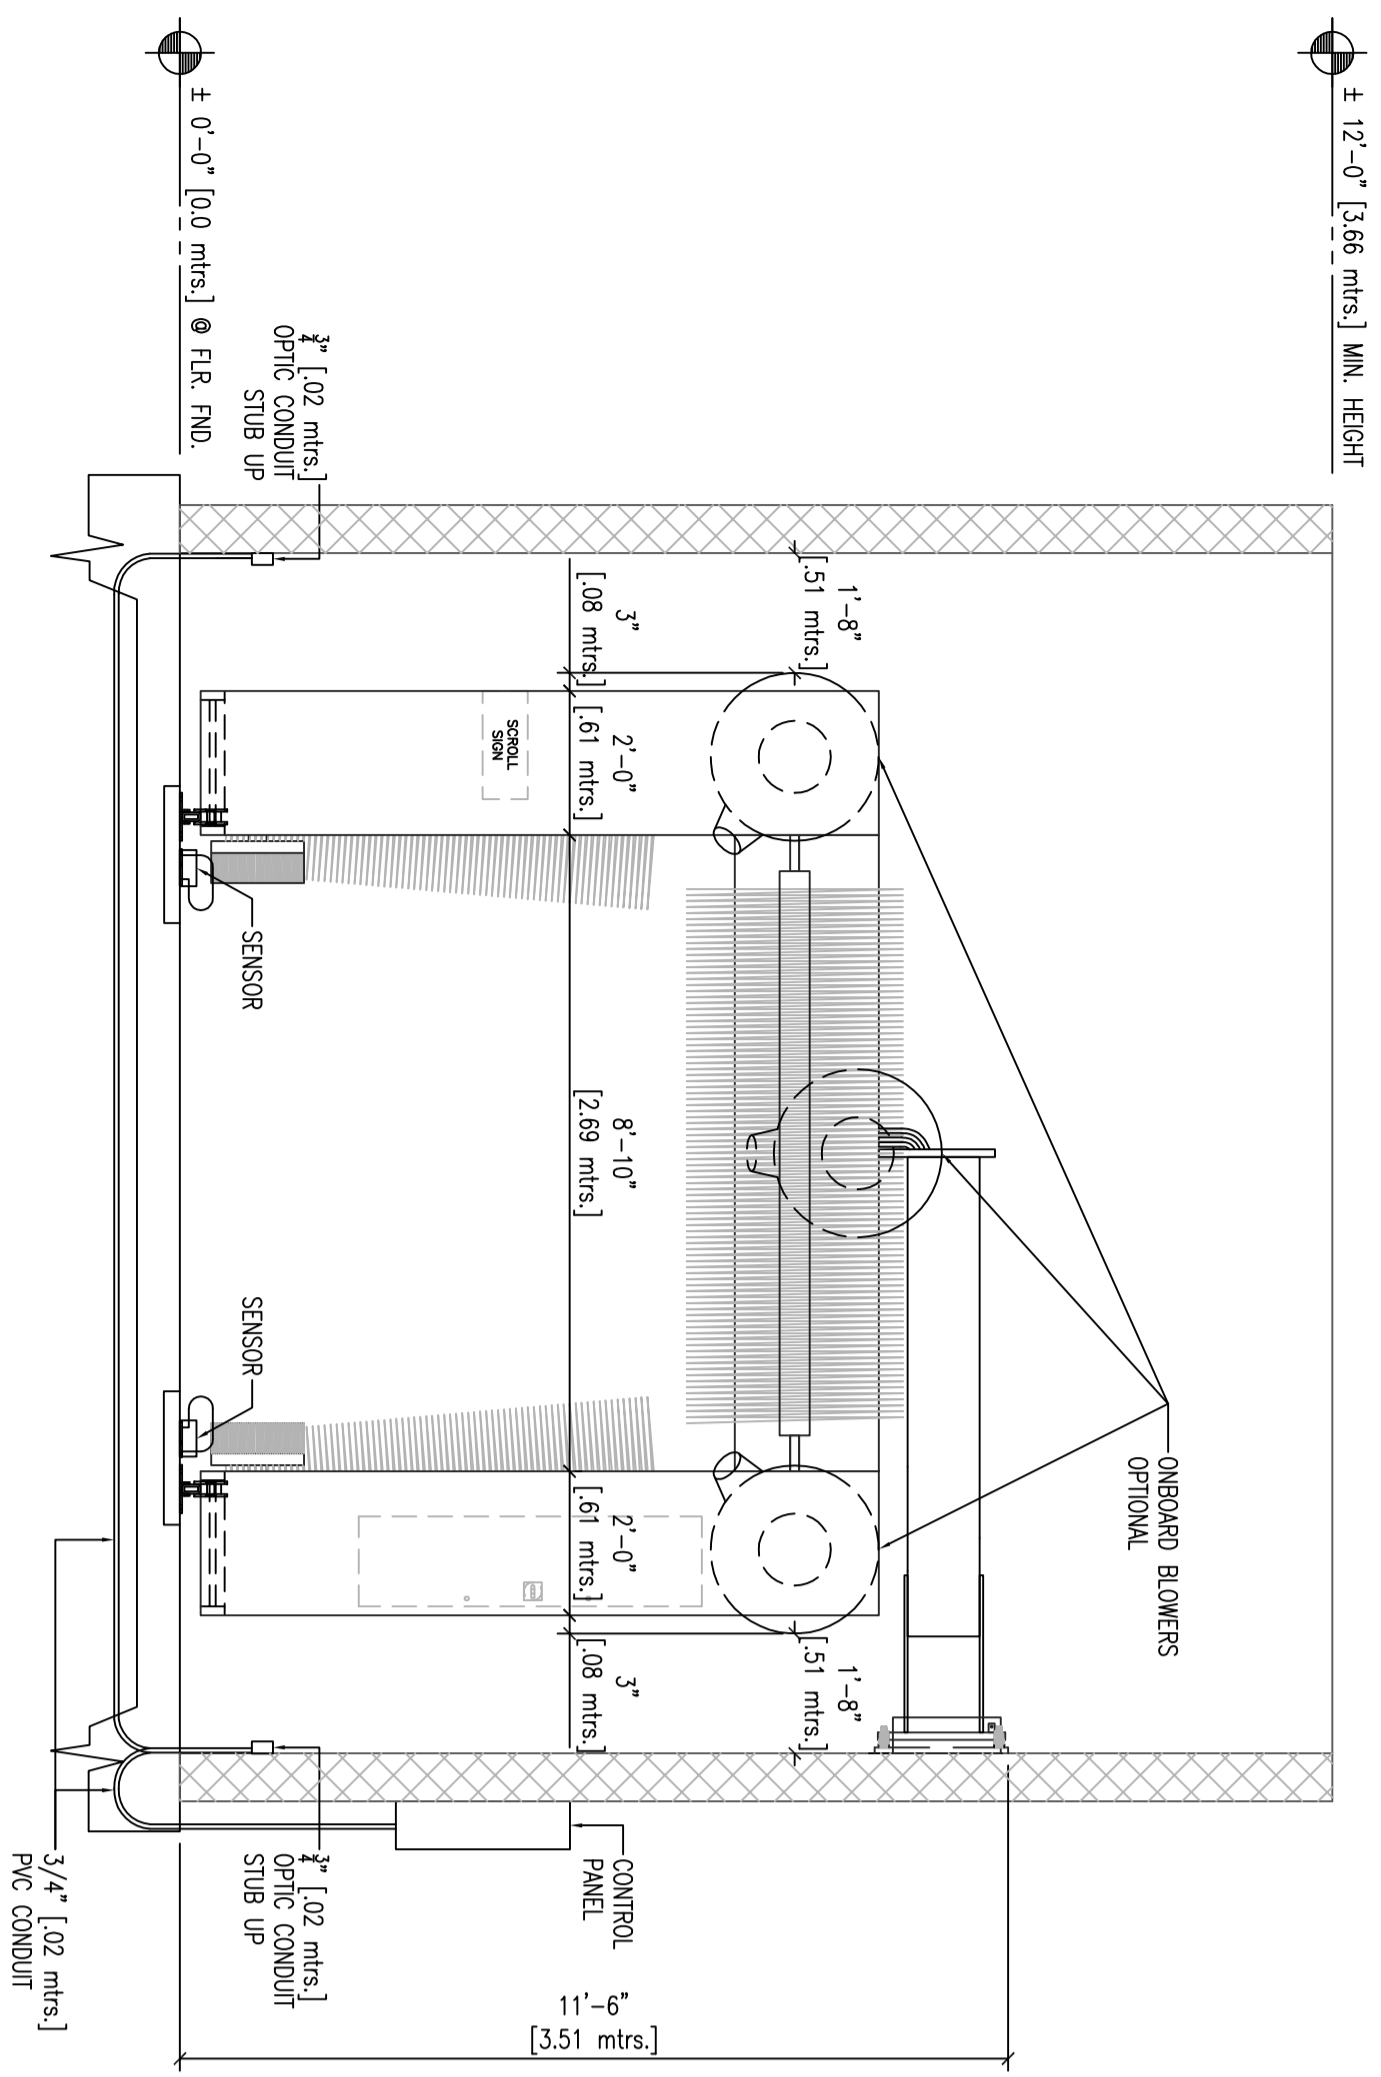

1 E-FUSION (FRONT VIEW)  
SCALE: 3/8" = 1'-0"

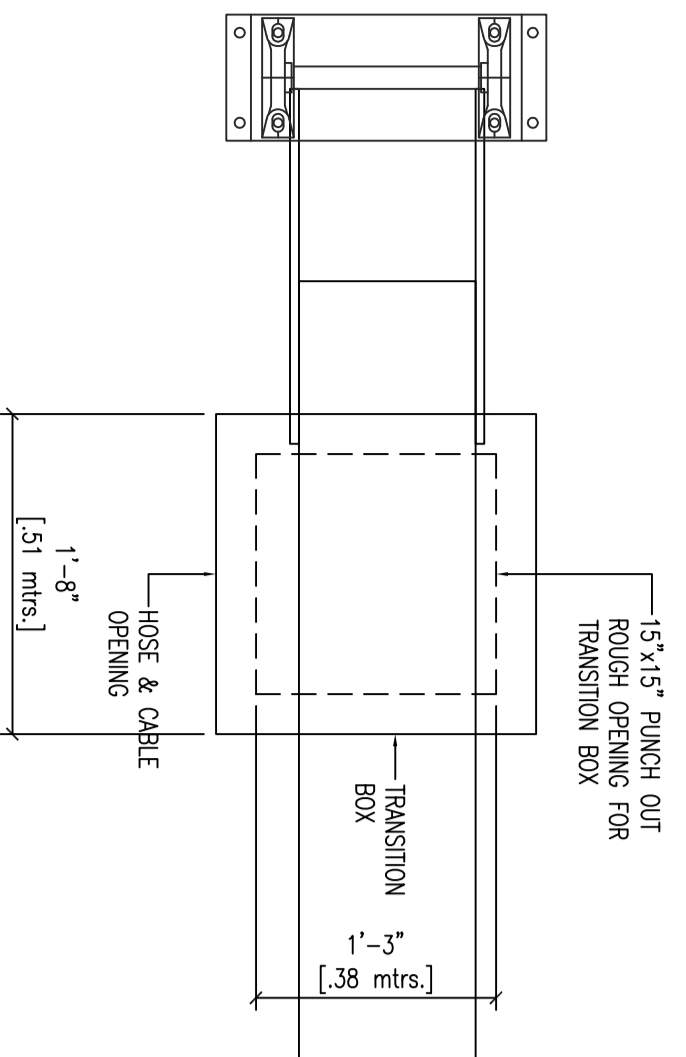


A E-FUSION (FRONT VIEW)  
SCALE: 1" = 1'-0"

B NOT USED  
SCALE: N.T.S.

C NOT USED  
SCALE: N.T.S.

D NOT USED  
SCALE: N.T.S.

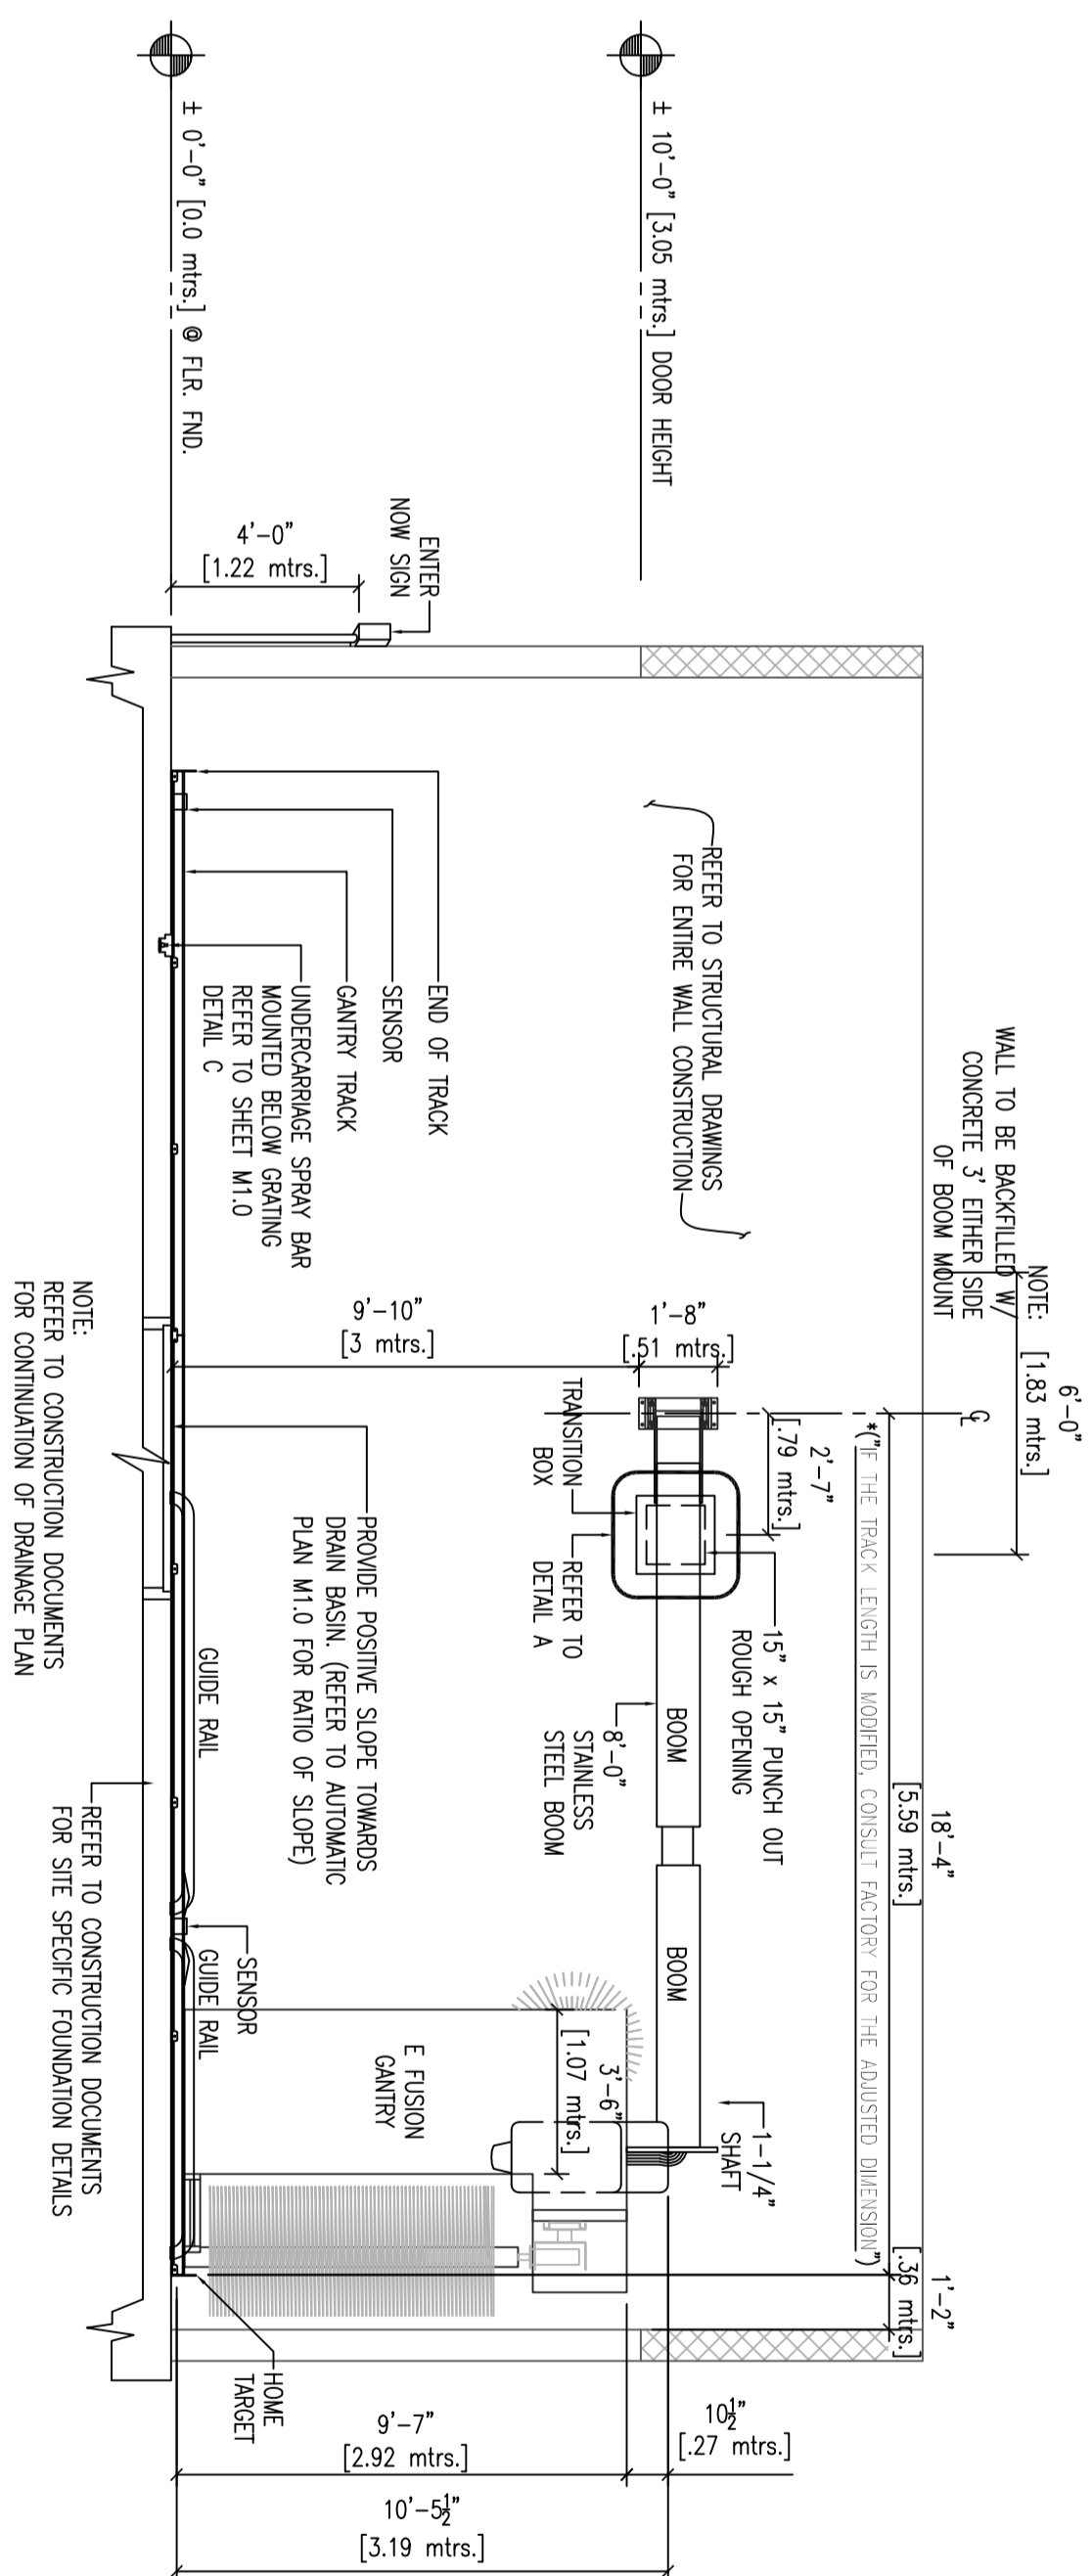



2 E-FUSION (SIDE VIEW)  
SCALE: 1/4" = 1'-0"

NOTE:  
ALL ELEVATION DIMENSIONS ARE FROM  
BOTTOM OF GANTRY TRACK MOUNTING  
FOOT.


NOTE: PLEASE DO NOT SCALE DRAWING  
CONTACT JCC FOR ANY DISCREPANCIES  
1-800-999-9878.

OWNER: <b>JIM COLEMAN COMPANY</b> 5842 WEST 34th STREET HOUSTON, TX 77092			
SHEET NAME: <b>e-FUSION ELEVATIONS &amp; DETAILS</b>			
SCALE: AS SHOWN	DATE: 01/16/2012	DRAWN BY: JTREVINO	APPROVED BY: J.TRUELOVE / R.WITTE
DRAWING ACO:	EQUIPMENT ACO:	FILE NAME: T:\W-e-FUSION\ef-M1.A.dwg	

ENGINEER SEAL OR APPROVAL:	
SHEET:	<b>ef-M1.A</b>

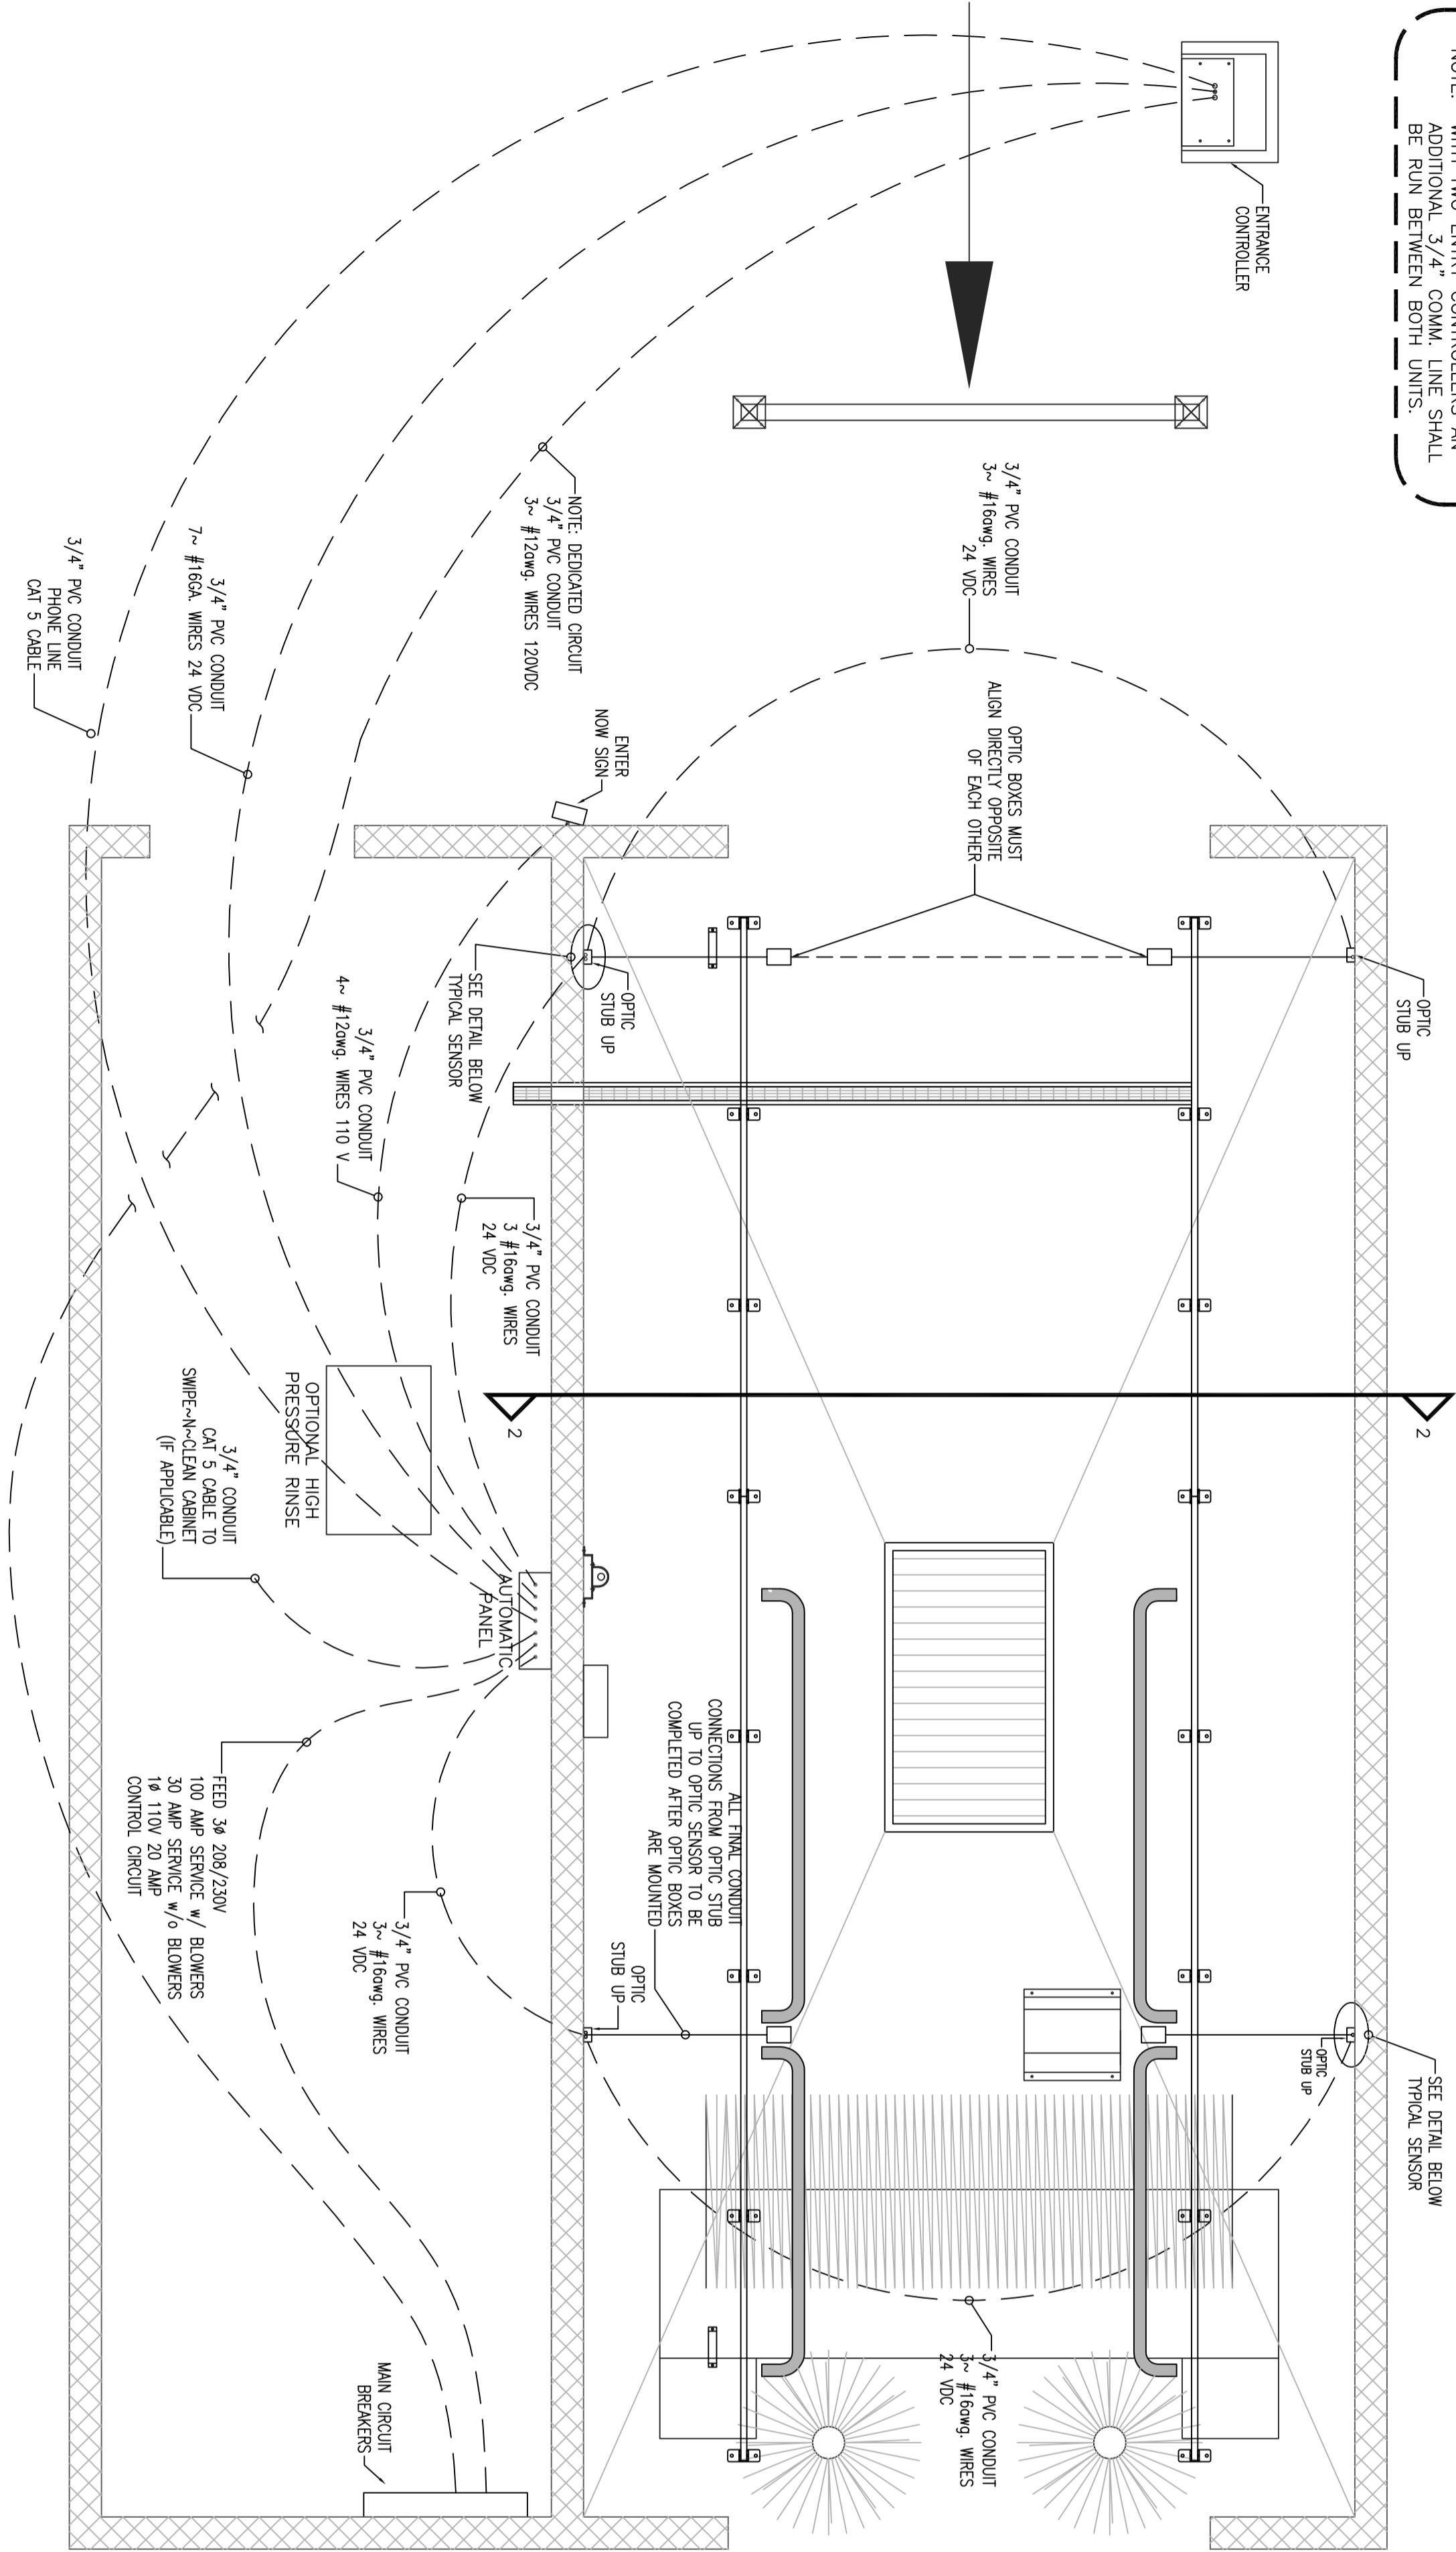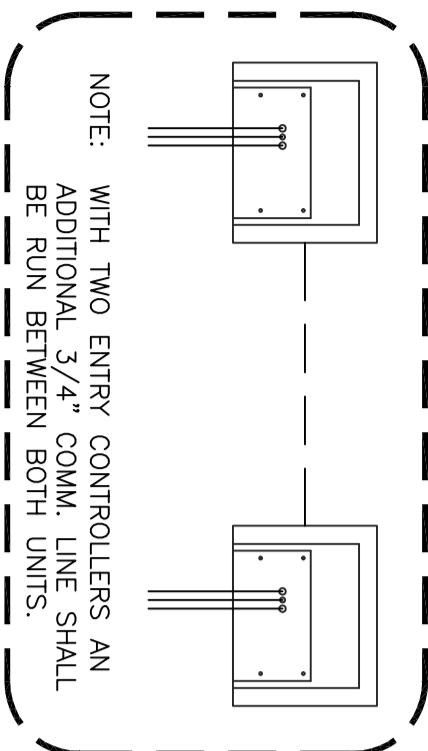

1 eFUSION CONDUIT RUNS  
SCALE: 3/8" = 1'-0"

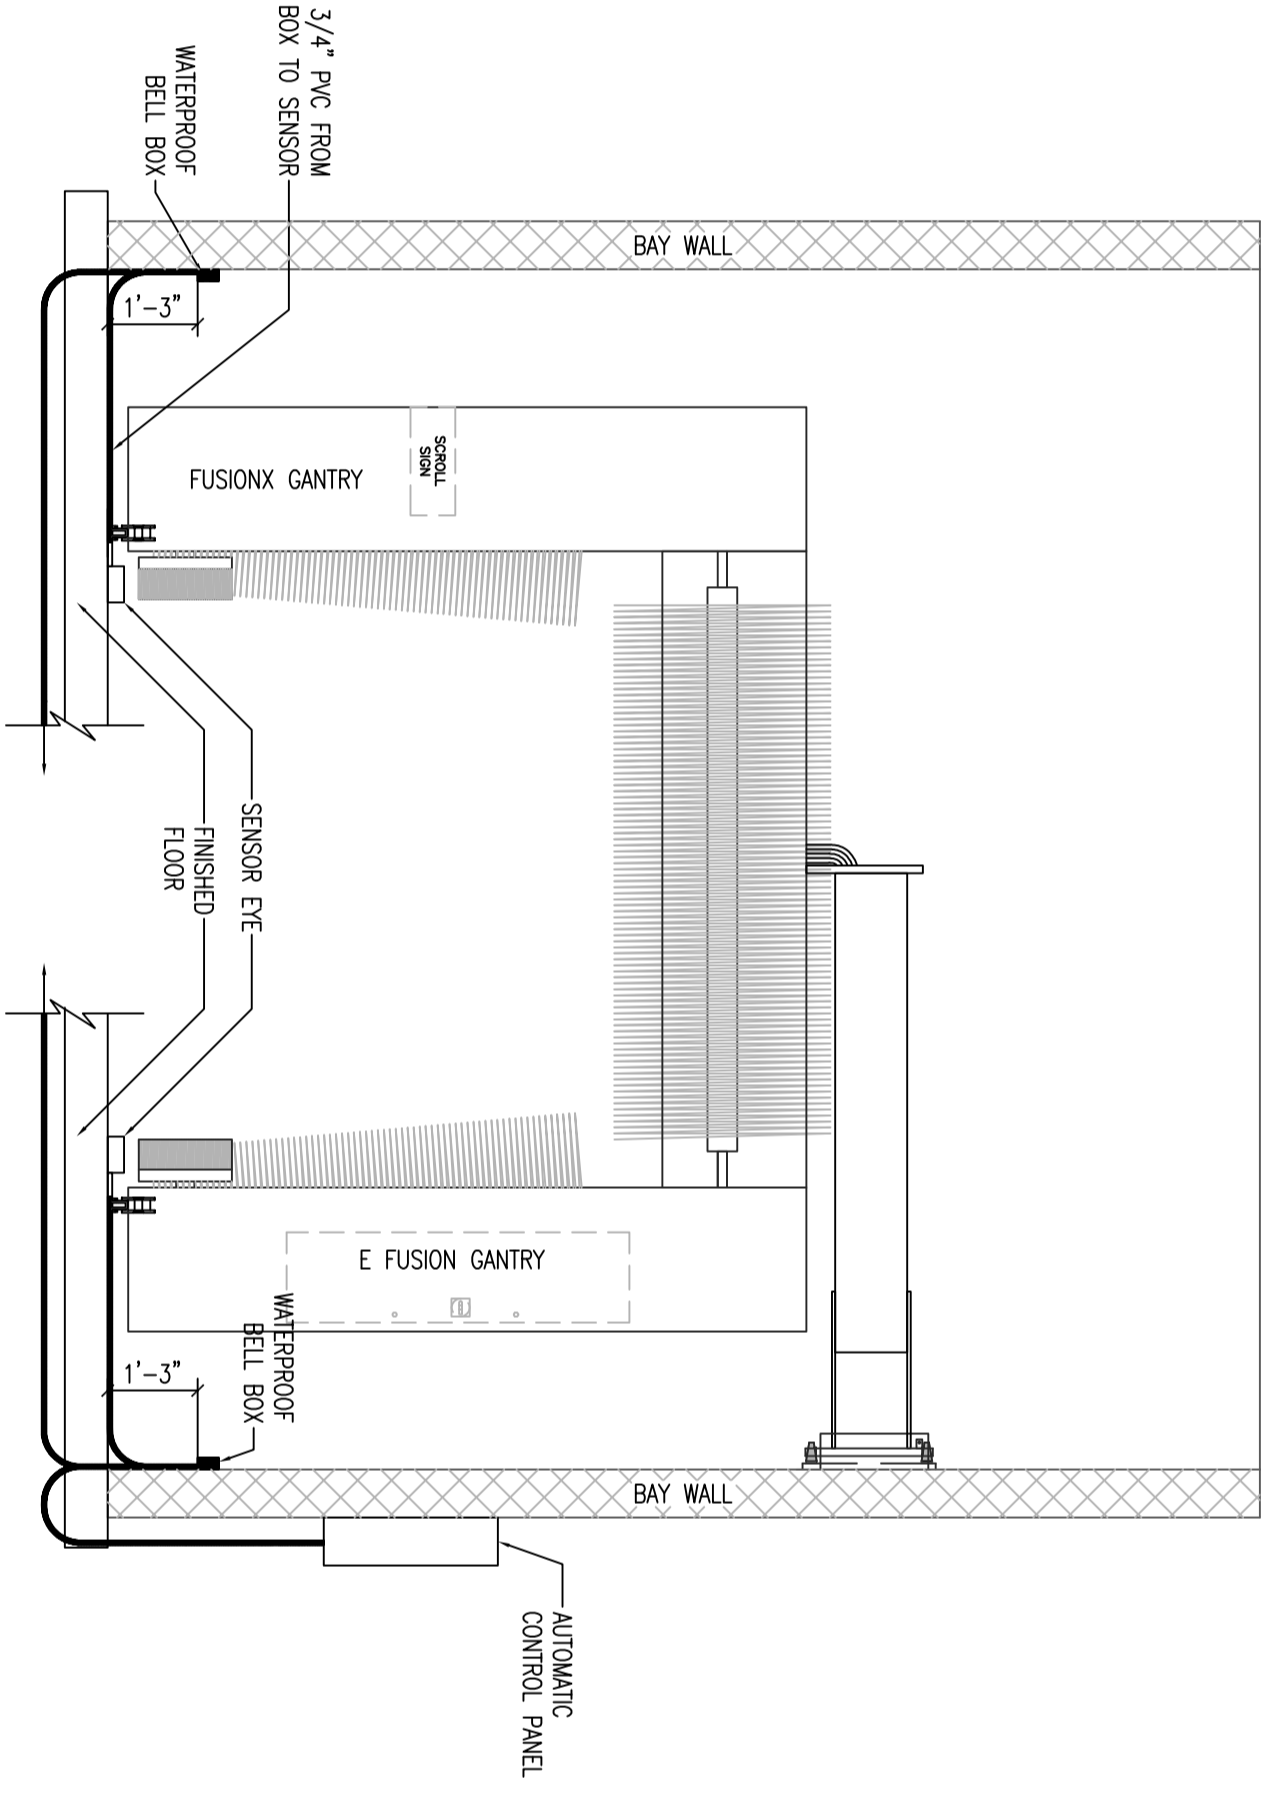

2 eFUSION ELEVATION DETAILS  
SCALE: 3/8" = 1'-0"

World Class Manufacturing in Car Wash Equipment


HOME OFFICE: 5842 WEST 34th STREET  
HOUSTON, TEXAS 77062  
PH: 1-800-999-9878 FAX: 713-563-8624  
www.jcolmanco.com

OWNER: <b>JIM COLEMAN COMPANY</b> 5842 WEST 34th STREET HOUSTON, TX 77092			
SHEET NAME: <b>e-FUSION e-FUSION ELECTRICAL CONDUIT RUNS AND ELEVATION DETAILS</b>			
SCALE: AS SHOWN	DATE: 01/16/2012	DRAWN BY: J.TREVINO	APPROVED BY: J.TRUELOVE / R.WITTE
DRAWING AKO:	EQUIPMENT AKO:	FILE NAME: T:\W-eFUSION\ef-M2.0.dwg	

REVISIONS			
ENGINEER SEAL OR APPROVAL:			



SHEET:  
**ef-M2.0**

# FUSION X / E FUSION EYE WIRING DIAGRAM

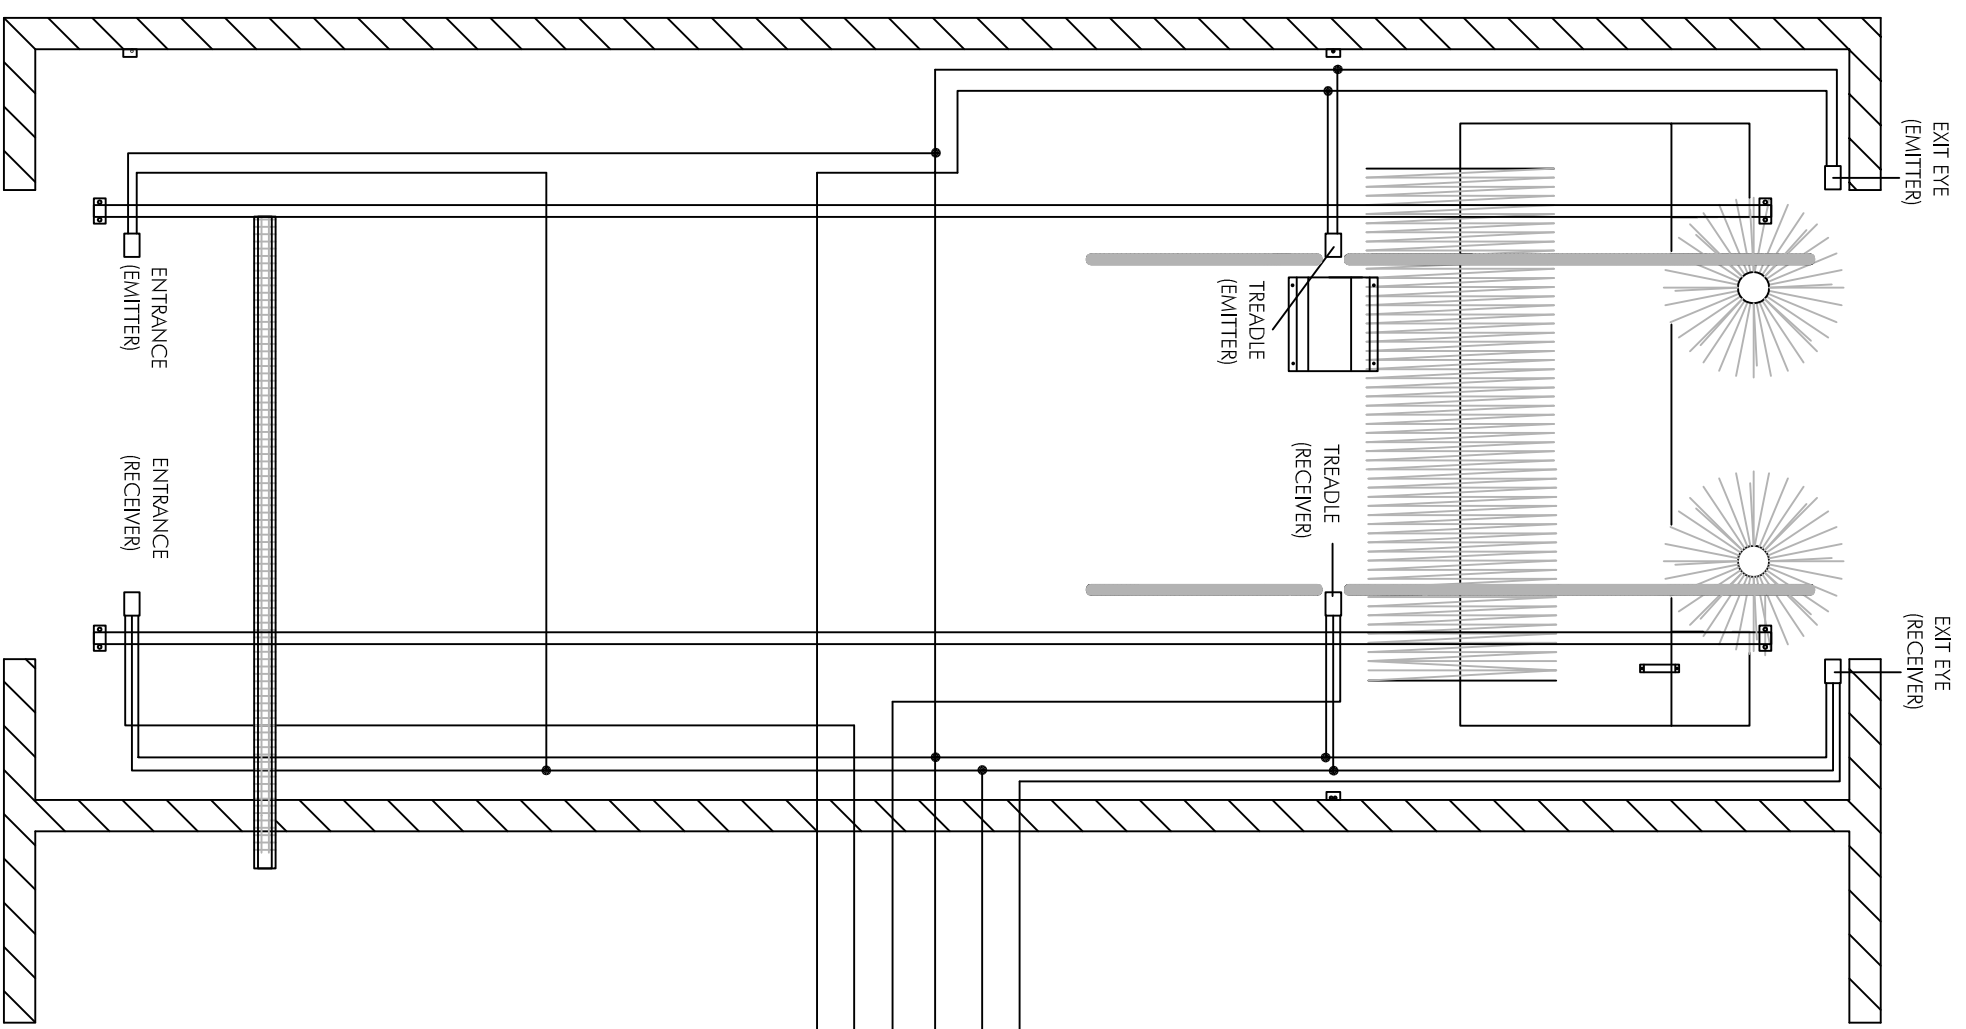

FUSION X / E FUSION  
ELECTRICAL CONTROL PANEL

SRT2-ID16 (INPUTS) CHANNEL 2014

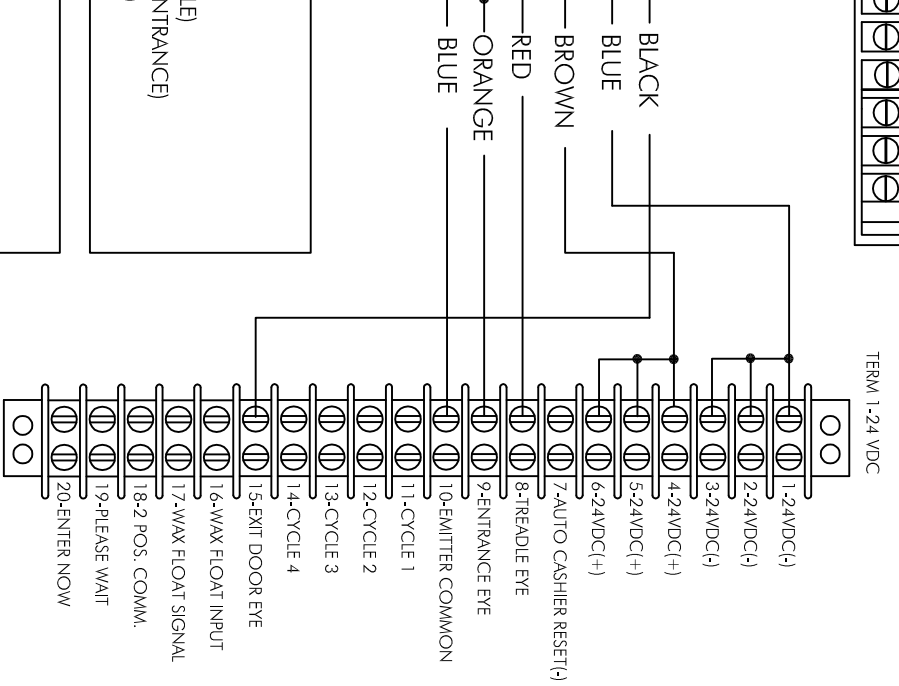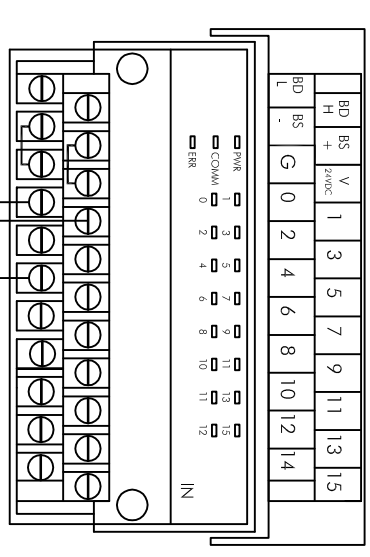


EYES RECEIVER  
BLUE - BLUE  
BROWN - BROWN  
BLACK - RED (TREADLE)  
BLACK - ORANGE (ENTRANCE)  
BLACK - BLACK (EXIT)

EYES TRANSMIT  
BLUE - BLUE  
BROWN - BROWN

NOTE: CONNECT WHT/GRY/PINK  
WIRES FROM EYE CABLE TO  
BRN (24DC+)

- TERM 1-24 VDC
- 1-24VDC(+)
- 2-24VDC(+)
- 3-24VDC(+)
- 4-24VDC(+)
- 5-24VDC(+)
- 6-24VDC(+)
- 7-AUTO CASHIER RESET(+)
- 8-TREADLE EYE
- 9-ENTRANCE EYE
- 10-EMITTER COMMON
- 11-CYCLE 1
- 12-CYCLE 2
- 13-CYCLE 3
- 14-CYCLE 4
- 15-EXIT DOOR EYE
- 16-WAX FLOAT INPUT
- 17-WAX FLOAT SIGNAL
- 18-2 POS. COMM.
- 19-PLEASE WAIT
- 20-ENTER NOW

# FREE STAND BLOWER

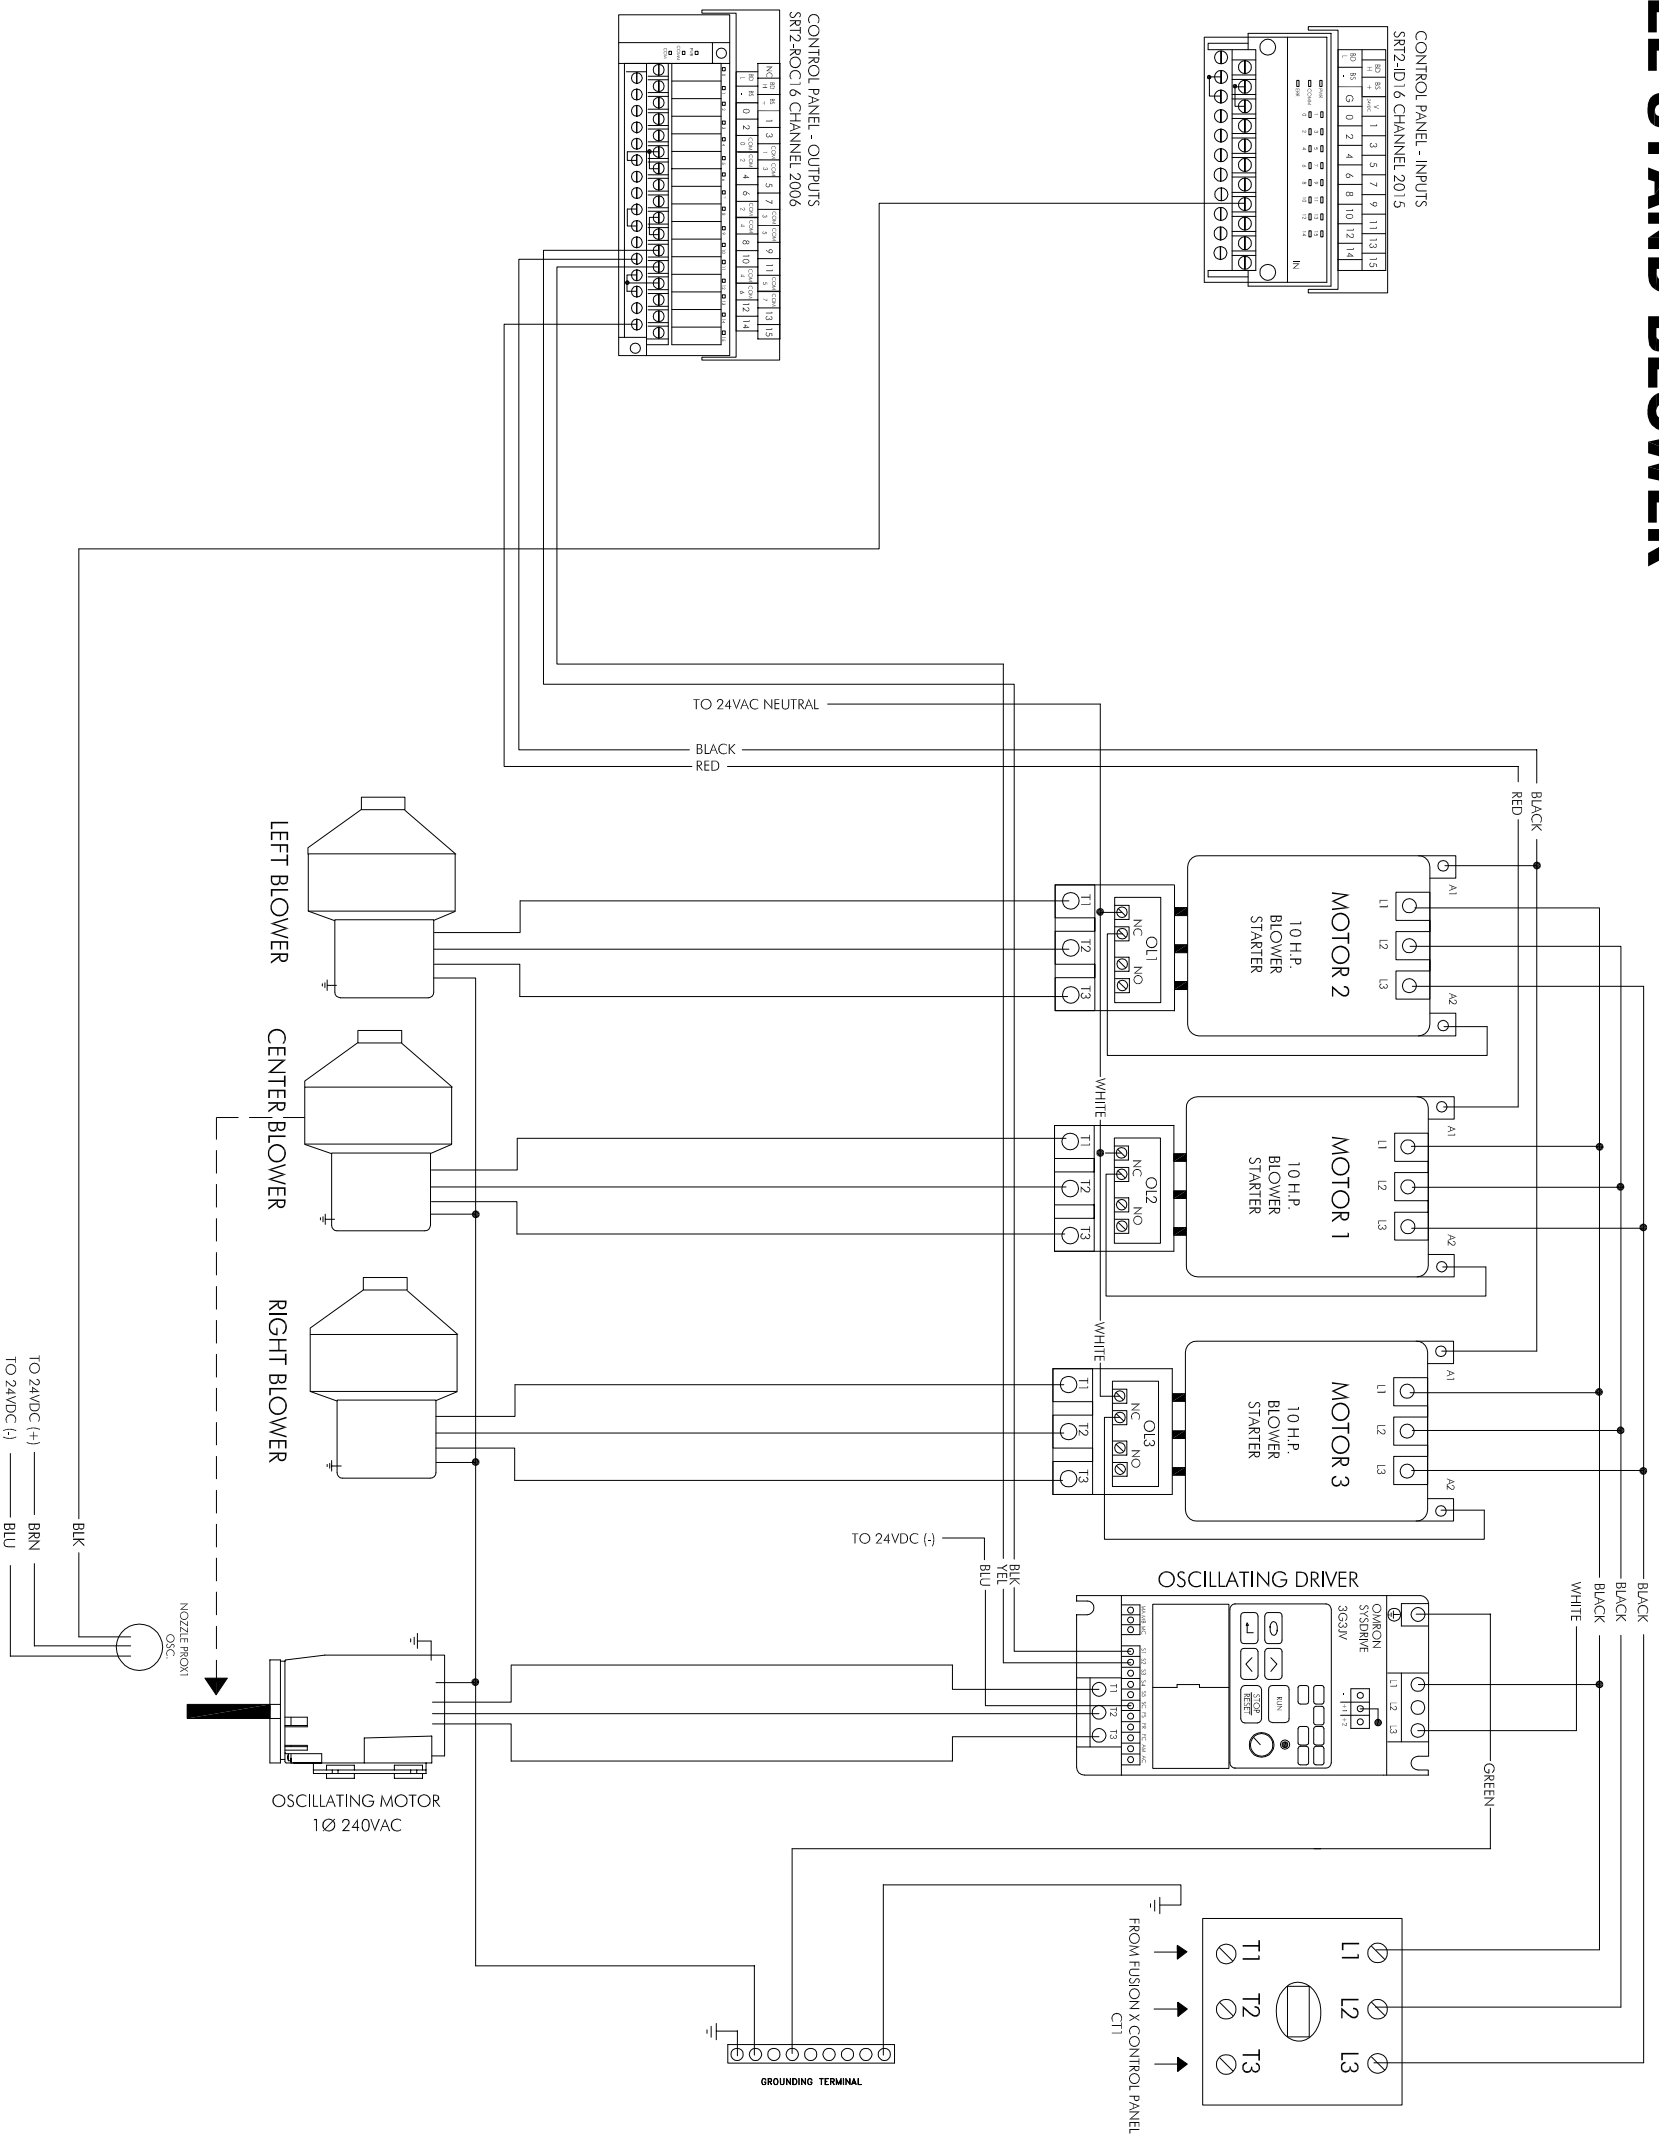


REVISIONS	OWNER: JIM COLEMAN COMPANY 5842 WEST 34TH STREET HOUSTON, TX 77092			
	SHEET NAME: 120/240 FREE STAND BLOWER SCHEMATIC			
	SCALE: AS SHOWN	DATE: 01/03/07	DRAWN BY: H.PHAM	APPROVED BY: J.TRUELOVE/R.COLEMAN/R.WITTE
	DRAWING AKO: N/A	EQUIPMENT AKO: N/A	FILE NAME: T:\BLOCKS\ELECTRICAL\FUSION\IGFXA	
	ENGINEER SEAL OR APPROVAL:			
SHEET:				
FSB.A				

**JIM COLEMAN COMPANY**  
**HANNA**

World Class Manufacturing In Car Wash Equipment

HOME OFFICE: 5842 WEST 34TH STREET  
HOUSTON, TEXAS 77092  
PH: 1-800-895-8078 FAX: 713-483-8624  
www.jcolmanco.com

# ON-BOARD BLOWER

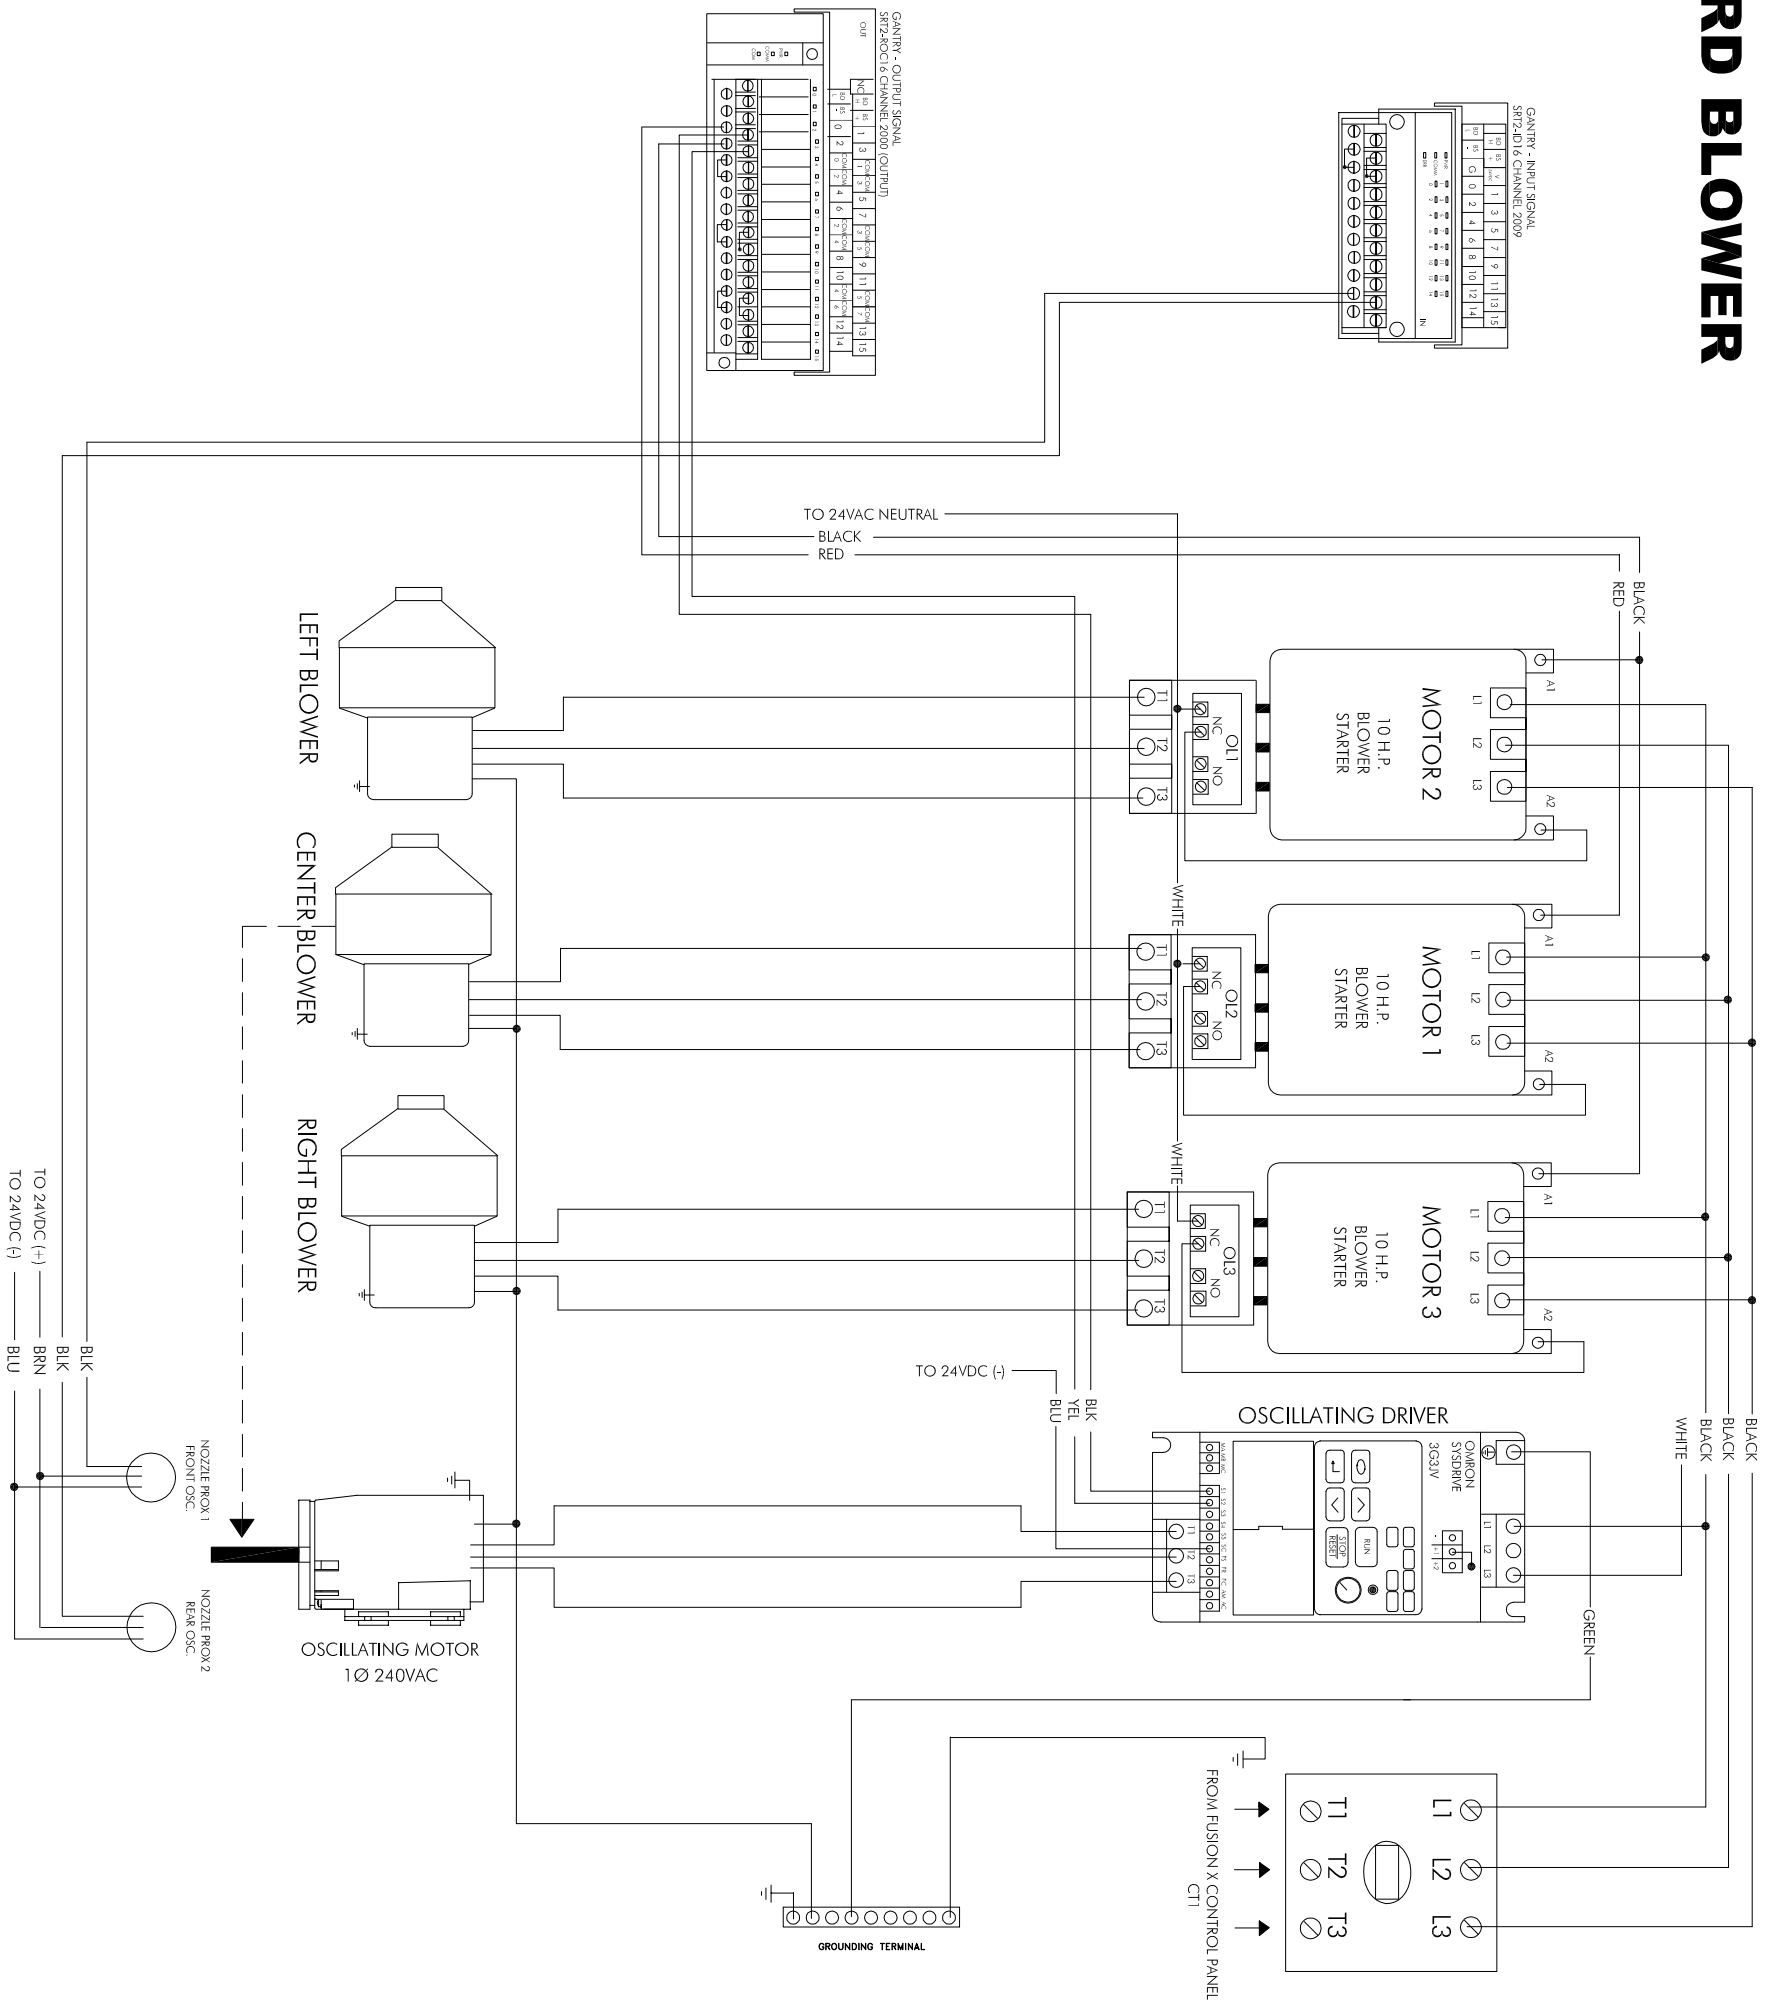

**JIM COLEMAN COMPANY**  
HANNA  
World Class Manufacturing In Car Wash Equipment

HOME OFFICE: 5842 WEST 34TH STREET  
HOUSTON, TEXAS 77092  
PH: 1-800-895-8878 FAX: 713-483-9824  
www.jcolmanco.com

OWNER: <b>JIM COLEMAN COMPANY</b> 5842 WEST 34TH STREET HOUSTON, TX 77092			
SHEET NAME: <b>120/240 ON-BOARD BLOWER SCHEMATIC</b>			
SCALE: AS SHOWN	DATE: 01/03/07	DRAWN BY: H.PHAM	APPROVED BY: J.TRUELOVE/R.COLEMAN/R.WITTE
DRAWING AKO: N/A	EQUIPMENT AKO: N/A	FILE NAME: T:\BLOCK\ELECTRICAL\FUSION\X\GPK.A	

REVISIONS	ENGINEER SEAL OR APPROVAL:

SHEET:
--------

OBB.A